


DFE File created by LitePro 2020 on 6/6/2023 5:57:54 PM

CALCULATION SUMMARY		DIMENSIONS	GRID / TYPE	# PTS	SPAC	GRIDP	AVE	MAX	MIN	MAX/MIN	AVG/MIN
New Area		10426X10926SFT	Direccl / HH	6303	1000	(*)	019	684	000	N/A	N/A

SYMBOL	DESCRIPTION	LETTER/ELEID	LAMP	LUMENS	MOUNTING/BALLAST	LF	Qty
DL-1	0) ECLIPSE LUMIN LP-1LEIGH-EBU 1) 70L LUP-LEDH-EBU-5K		(1) 92900099603	918	12FT mounting	0.95	6
LB-1	0) KVM LIGHTING 10983-20K-30 1) 18L VERNI-OLEE-50KIK			1698	42" Bollard	0.92	12
LL-3	0) ARCHITECTURAL A-FH-13-99LEP-BW 1) 1137 FH-13-99LEP-BW			331	15' Ft ht	0.92	15
				6581		0.92	18

AREA NAME	NO	DIMENSIONS	LUMENS / GSKNS	WATTS / 50 FT	Qty
New Area	001	10426X10926SFT	000	1	
		(0-1) (6)			
		(1-1) (2)			
		(1-3) (5)			
		(1-3) (8)			

- 4A Building Downlight
- 4VB Vehicular Bollard
- 4LB Illuminated Bollard
- 4B Pole Light Fixture

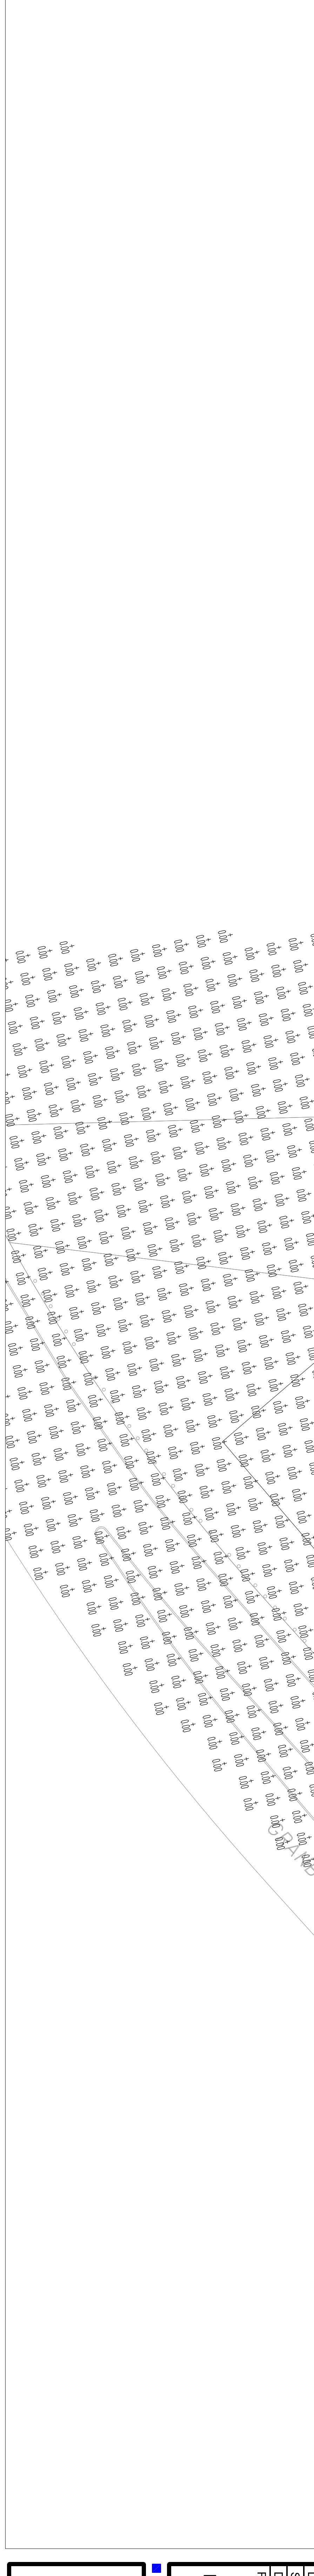

### Lighting Plan

Plains Elementary School  
Town of South Hadley  
South Hadley, MA

Project: 1108  
Date: 05/29/23  
Scale: RL  
Drawn By: RLS  
Revisions:

DD COST  
ESTIMATE SET

L1.4